

# PRESIDENT'S OFFICE SUITE ALTERATIONS

## RAMAPO COLLEGE OF NEW JERSEY 505 RAMAPO VALLEY ROAD, MAHWAH, NJ 07430




3 University Plaza Drive  
Suite 600  
Hackensack, NJ 07601  
T: 201.941.3040  
F: 201.941.3050  
www.rscarchitects.com

**LICENSE: NJ**  
JAH1171 Copied: NJA  
A10008 NJ  
12/10/15  
03/04/21 NJ  
11/28/15 NJ  
11/28/15 NJ  
11/28/15 NJ  
06/10/2015 NJ

Date: \_\_\_\_\_

RSC Architects retains ownership of this drawing. No part of this drawing may be reproduced or transmitted in any form or by any means electronic or mechanical, including photocopying, recording, or by any information storage and retrieval system, without the prior written permission of RSC Architects.

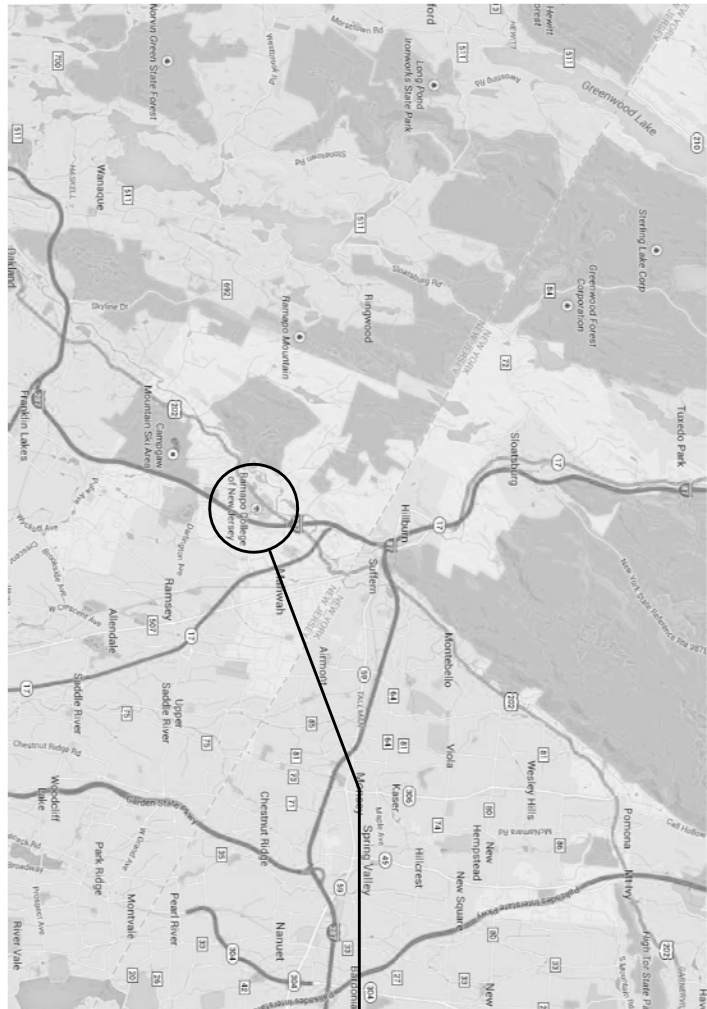

PROJECT  
LOCATION

### LIST OF DRAWINGS:

#### ARCHITECTURAL:

- A0.0 COVER SHEET
- A0.1 GENERAL NOTES, CODE INFORMATION, PARTITION TYPES ABBREVIATIONS, ACCESSIBILITY AND NOTES
- A1.0 DEMOLITION FLOOR PLAN AND NOTES
- A2.0 CONSTRUCTION FLOOR PLAN AND NOTES
- A2.1 ALTERNATES #1 AND #2
- A3.0 REFLECTED CEILING PLAN AND NOTES
- A8.0 ENLARGED FLOOR PLANS, INTERIOR ELEVATIONS AND SCHEDULES.
- A8.1 ACCESSORY SCHEDULE, RISER DIAGRAMS, SIGNS, INTERIOR ELEVATION AND FINIS SCHEDULE

#### MECHANICAL:

- M1.0 MECHANICAL FLOOR PLAN AND NOTES

#### ELECTRICAL:

- E1.0 ELECTRICAL POWER/DATA FLOOR PLAN AND NOTES
- E2.0 ELECTRICAL LIGHTING FLOOR PLAN AND NOTES

### LOCATION MAP

SCALE: NOT TO SCALE



PROJECT  
LOCATION

### CAMPUS MAP

SCALE: NOT TO SCALE



PLEASE NOTE THAT SOME OF  
THE DRAWINGS HAVE BEEN  
REVISED. REFER TO ADDENDUM  
NO. 2

RAMAPO COLLEGE  
OF NEW JERSEY

PRESIDENT'S  
OFFICE SUITE  
ALTERATIONS

505 RAMAPO VALLEY ROAD  
MAHWAH, NJ 07430  
RCNJ PROJECT NO. 201-4-24-03C  
PROJECT NO. 94-14-002

REV/DATE	DESCRIPTION
-	5/1/15 OWNER REVIEW SET
-	12/10/15 ISSUED FOR BID
Δ	1/28/16 ADDENDUM #2

DRAWING TITLE

COVER SHEET

CHECKED BY: JAM DRAWN BY: RC

DRAWING NO.

A0.0

DWG. NO. 1 OF 11